


UNIT F FOUNDATION PLAN
SCALE: 1/8" = 1'-0"

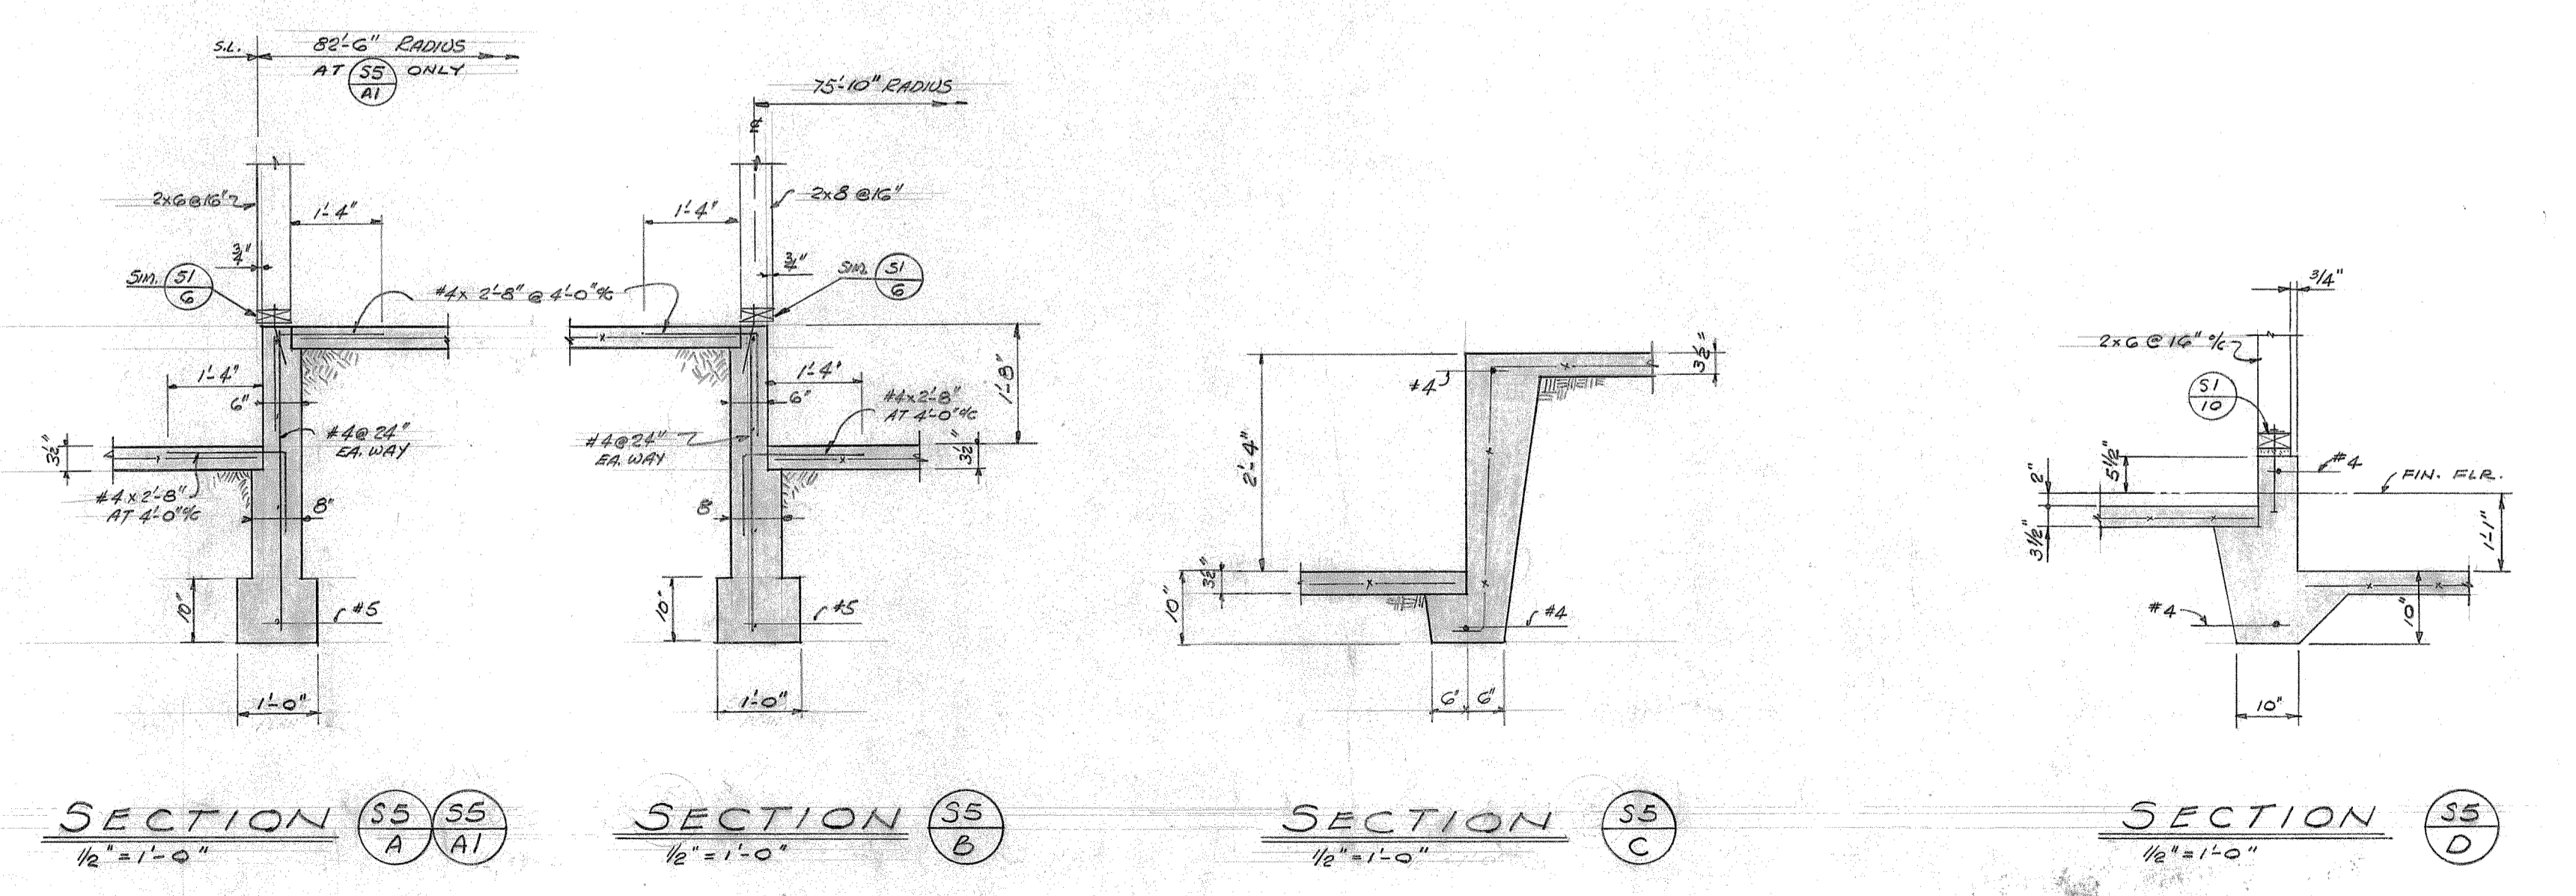

CONTRACTOR TO VERIFY ALL DIMENSIONS AT THE JOB

W. H. Wright
ARCHITECT
W. H. Wright
STRUCTURAL ENGINEER

MECHANICAL ENGINEER
ELECTRICAL ENGINEER
CIVIL ENGINEER

K I S T N E R, W R I G H T & W R I G H T
ARTHUR J. RENDON & LEWIS K. OSBORN, ASSOCIATES
ARCHITECTS AND ENGINEERS
LOS ANGELES, CALIFORNIA

STATE OF CALIFORNIA - DEPARTMENT OF PUBLIC WORKS
DIVISION OF ARCHITECTURE
21890 APPROVED JAN 30 1962
S. V. ...
PRINCIPAL STRUCTURAL ENGINEER

UNIT "F" FOUNDATION PLAN
DATE: 1/22/62
DR. BY: ...
CHECKED BY: ...
JOB NO.: 61-37
NOGALES HIGH SCHOOL INC. II
LA PUENTE UNION HIGH SCHOOL DISTRICT
LA PUENTE, CALIFORNIA

SHEET NO. 5
OF 153 SHEETS